




Date :	6/5/2019	Sheet Title	FACILITY SITE PLAN	State of California DGS Department of General Services	Real Estate Services Division Project Management and Development Branch Architecture & Engineering Section 707 Third Street, Suite 4-105 West Sacramento, California 95605 Contact Phone # 916-375-4254	PLAN 1 OF 4
PMDB Project # :	2019-SOC-57411	Project	YOLO COUNTY FAIRGROUNDS			
Budget Package # :		Department	GENERAL SERVICES			
Project Contact :	SCOTT MCDONELL	Location	WOODLAND			

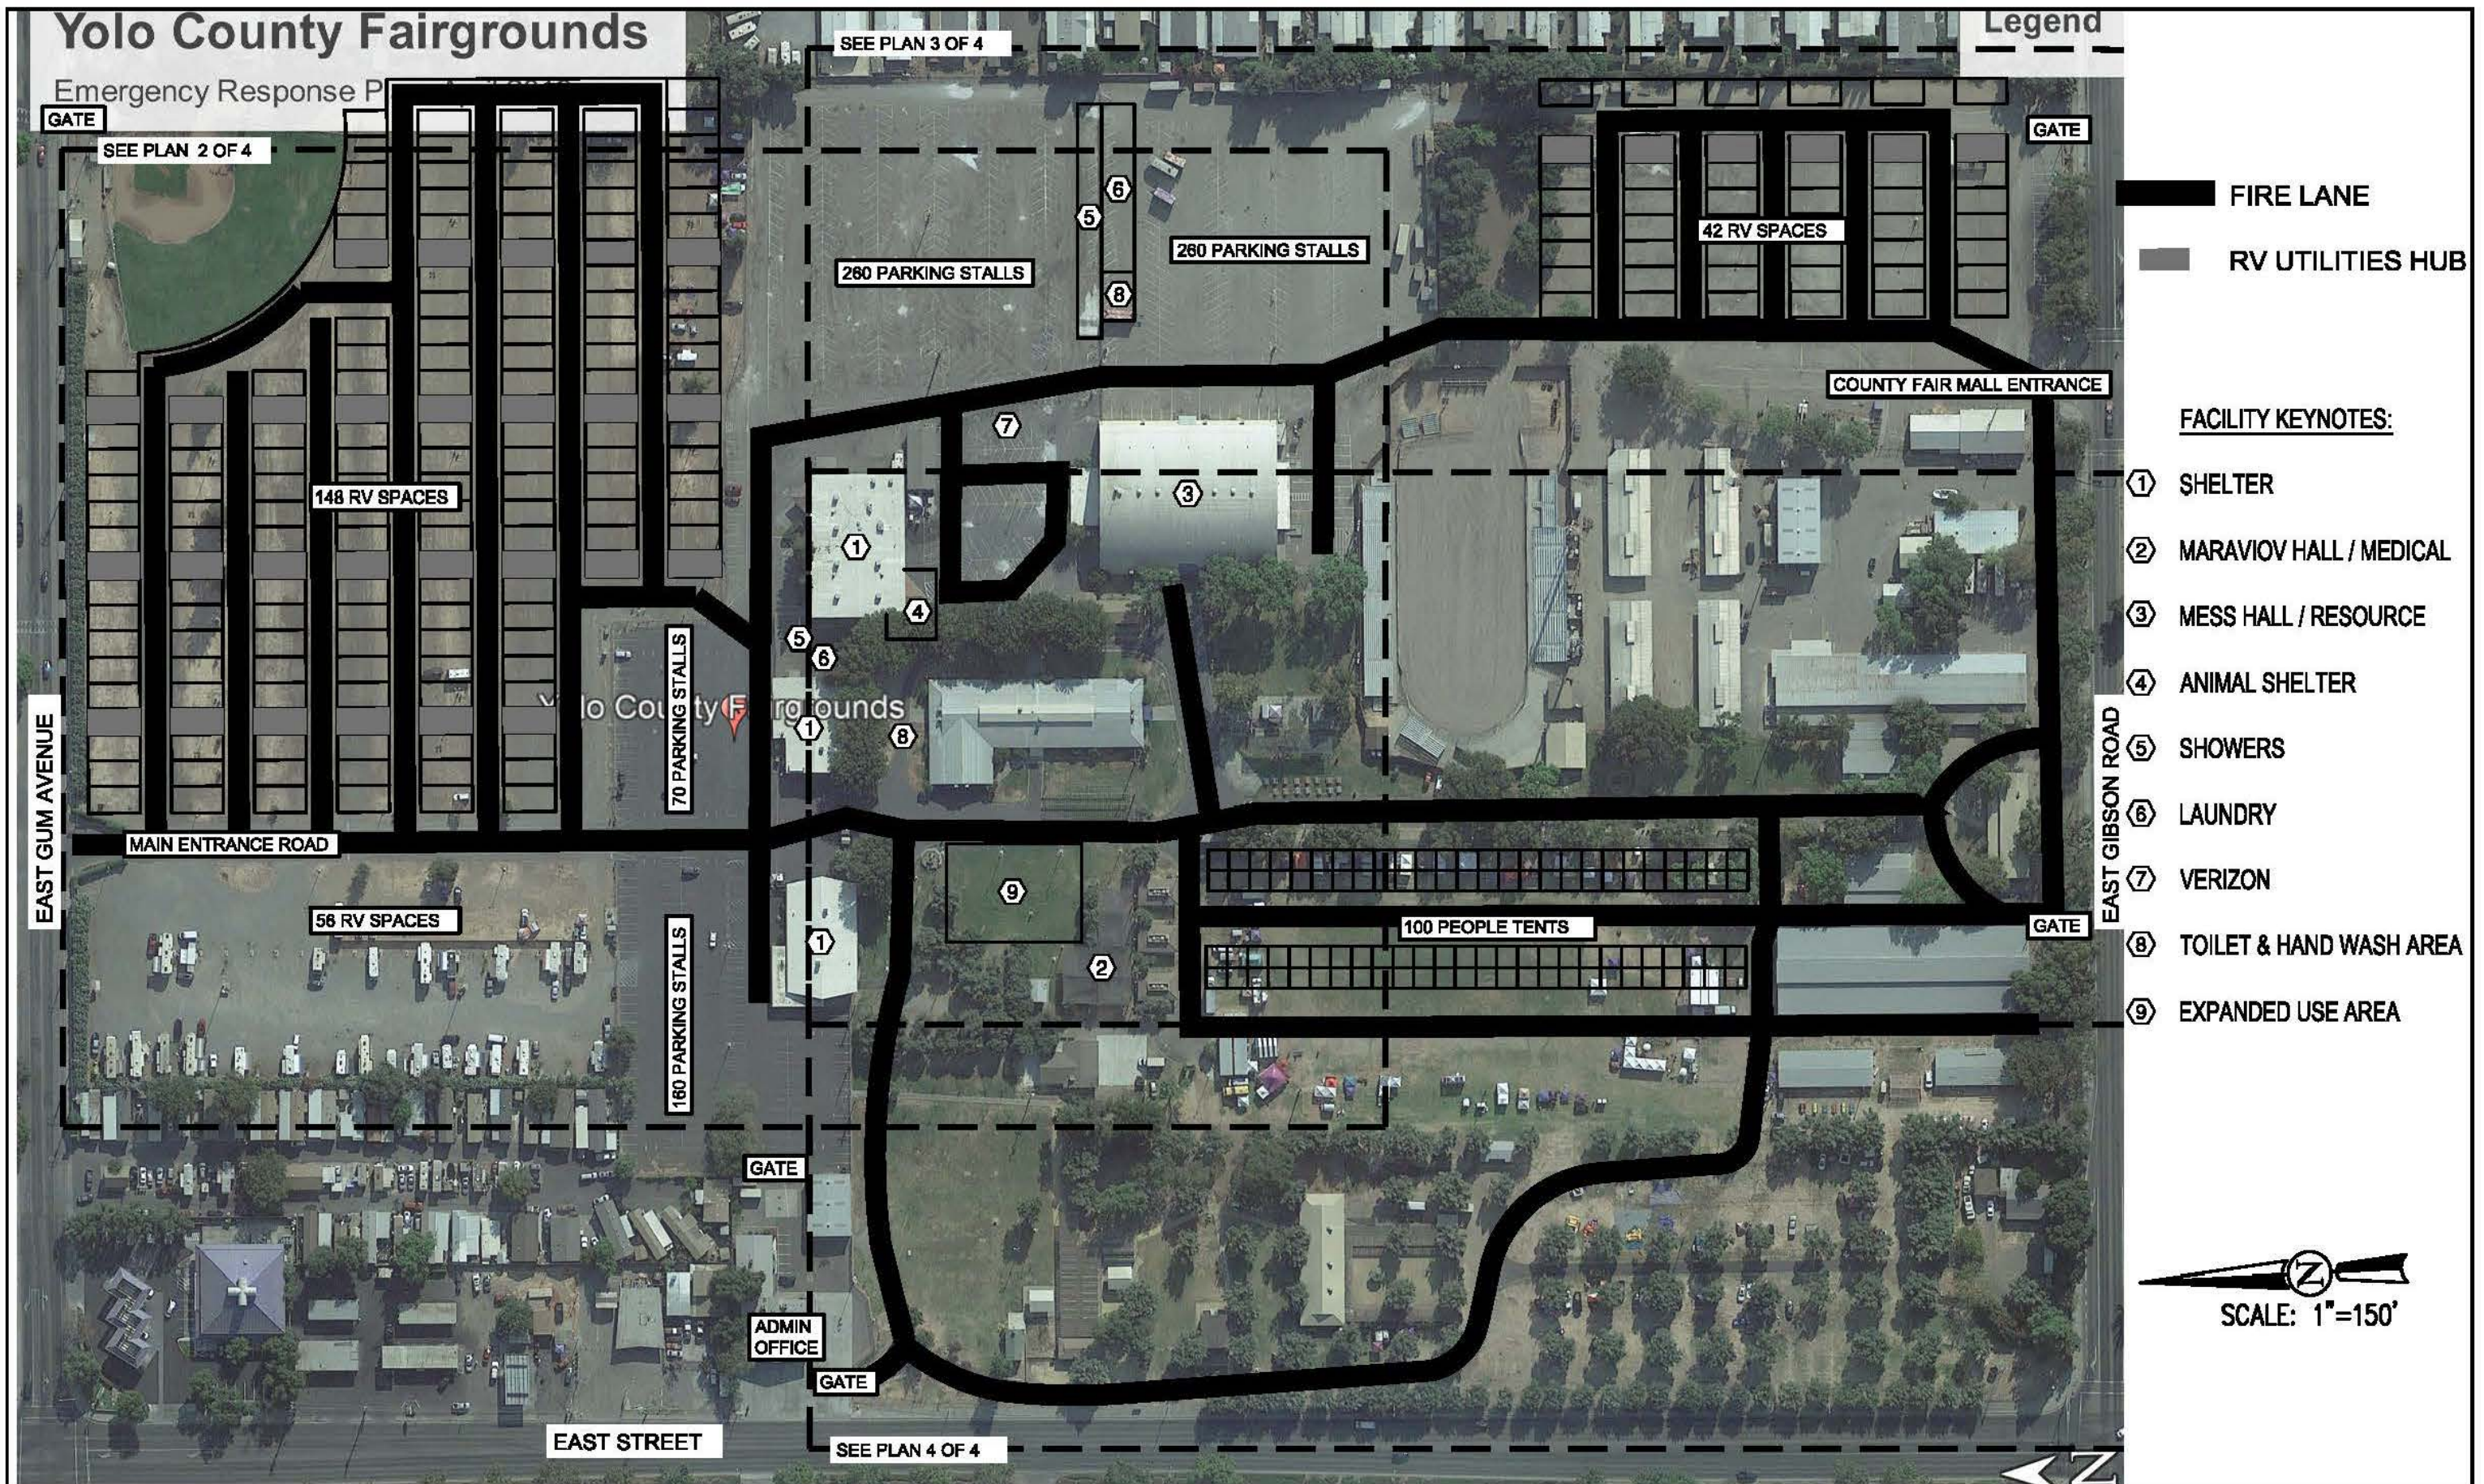


- LEGEND:**
- POWER POLE WITH ELECTRICAL OUTLETS
 - POWER BOX WITH OUTLETS
 - POWER & WATER
 - FULL RV HOOKUPS
 - WATER & SEWER
 - SANITARY SEWER
 - SEWER MANHOLE
 - DUMP STATION
 - DRAIN INLET
 - WATER MAIN
 - FIRE HYDRANT
 - HOSE BIB
 - BACKFLOW PREVENTER

SCALE: 1"=100'

Date :	6/5/2019	Sheet Title	FACILITY SITE PLAN
PMDB Project # :	2019-SOC-57411	Project	YOLO COUNTY FAIRGROUNDS
Budget Package # :		Department	GENERAL SERVICES
Project Contact :	SCOTT MCDONELL	Location	WOODLAND

State of California Department of General Services	Real Estate Services Division Project Management and Development Branch Architecture & Engineering Section 707 Third Street, Suite 4-105 West Sacramento, California 95605 Contact Phone # 916-375-4254	PLAN 2 OF 4

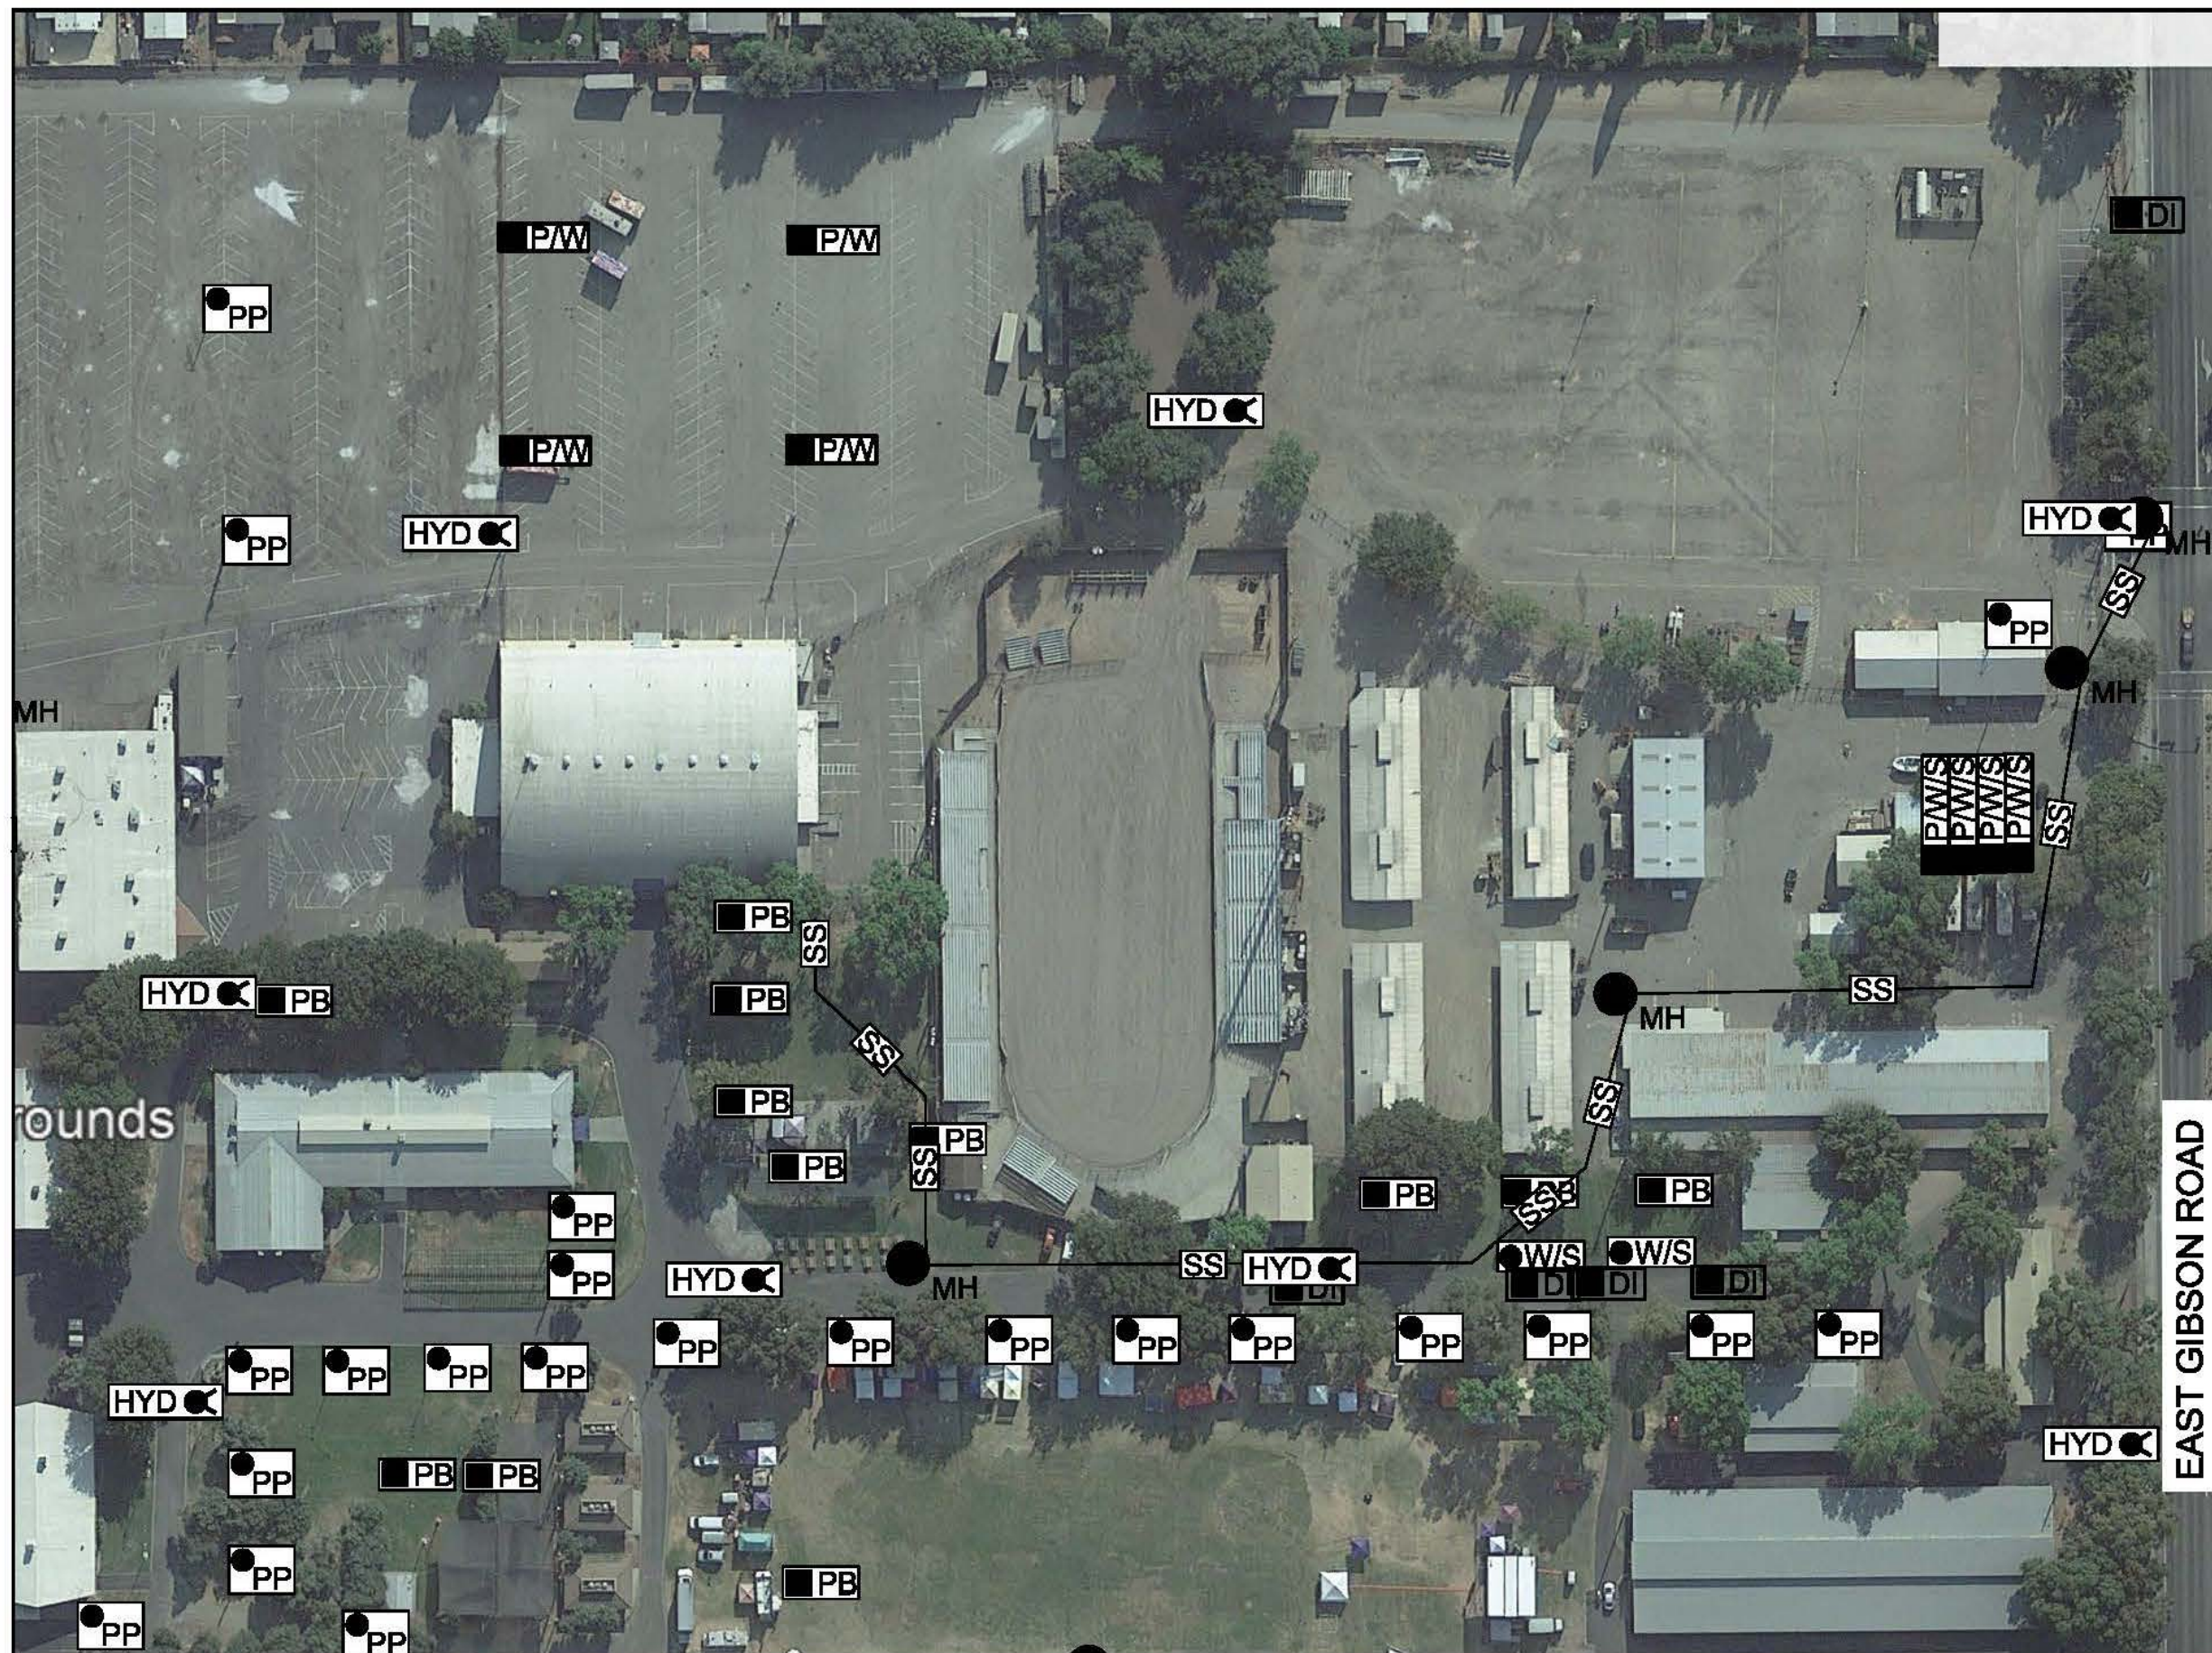

- LEGEND:**
- PP POWER POLE WITH ELECTRICAL OUTLETS
 - PB POWER BOX WITH OUTLETS
 - P/W POWER & WATER
 - P/W/S FULL RV HOOKUPS
 - W/S WATER & SEWER
 - SS SANITARY SEWER
 - MH SEWER MANHOLE
 - DS DUMP STATION
 - DI DRAIN INLET
 - WM WATER MAIN
 - HYD FIRE HYDRANT
 - HB HOSE BIB
 - BFP BACKFLOW PREVENTER


 SCALE: 1"=100'

Date :	6/5/2019	Sheet Title	FACILITY SITE PLAN
PMDB Project # :	2019-SOC-57411	Project	YOLO COUNTY FAIRGROUNDS
Budget Package # :		Department	GENERAL SERVICES
Project Contact :	SCOTT MCDONELL	Location	WOODLAND

State of California DGS Department of General Services	Real Estate Services Division Project Management and Development Branch Architecture & Engineering Section 707 Third Street, Suite 4-105 West Sacramento, California 95605 Contact Phone # 916-375-4254
PLAN 3 OF 4	



- LEGEND:**
- POWER POLE WITH ELECTRICAL OUTLETS
 - POWER BOX WITH OUTLETS
 - POWER & WATER
 - FULL RV HOOKUPS
 - WATER & SEWER
 - SANITARY SEWER
 - SEWER MANHOLE
 - DUMP STATION
 - DRAIN INLET
 - WATER MAIN
 - FIRE HYDRANT
 - HOSE BIB
 - BACKFLOW PREVENTER

SCALE: 1"=100'

Date :	6/5/2019	Sheet Title	FACILITY SITE PLAN
PMDB Project # :	2019-SOC-57411	Project	YOLO COUNTY FAIRGROUNDS
Budget Package # :		Department	GENERAL SERVICES
Project Contact :	SCOTT MCDONELL	Location	WOODLAND

State of California
Department of General Services

Real Estate Services Division
Project Management and Development Branch
Architecture & Engineering Section
707 Third Street, Suite 4-105
West Sacramento, California 95605
Contact Phone # 916-375-4254

PLAN
4 OF 4